


THE DRAWING, SPECIFICATIONS AND OTHER DOCUMENTS PREPARED BY THE ARCHITECT FOR THIS PROJECT ARE INSTRUMENTS OF THE ARCHITECT'S SERVICE FOR USE SOLELY WITH RESPECT TO THIS PROJECT. THE ARCHITECT SHALL BE DEEMED THE AUTHOR OF THESE DOCUMENTS IN SMALL LETTERS AND COMMON LAW, STATUTORY AND OTHER RESERVED RIGHTS, INCLUDING THE COPYRIGHT.

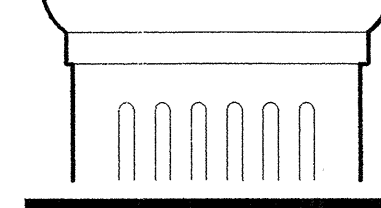

AEC

design building concepts

29756 Desert Willow Blvd
Queen Creek, Arizona 85243
ph. 480.882.9633
fax. 480.445.9795
www.aecdesigns.com
email: brian@aecdesigns.com




Architecture Plus L.L.C.
GARDEN CITY · DODGE CITY · DENVER
ARCHITECTURE

PLANNING
INTERIORS

402 E. FULTON 620.276.2872
GARDEN CITY, KANSAS 67846
FAX 620.276.7679
archplus@architectureplus.net

date
Feb 2007

drawn by
Brian

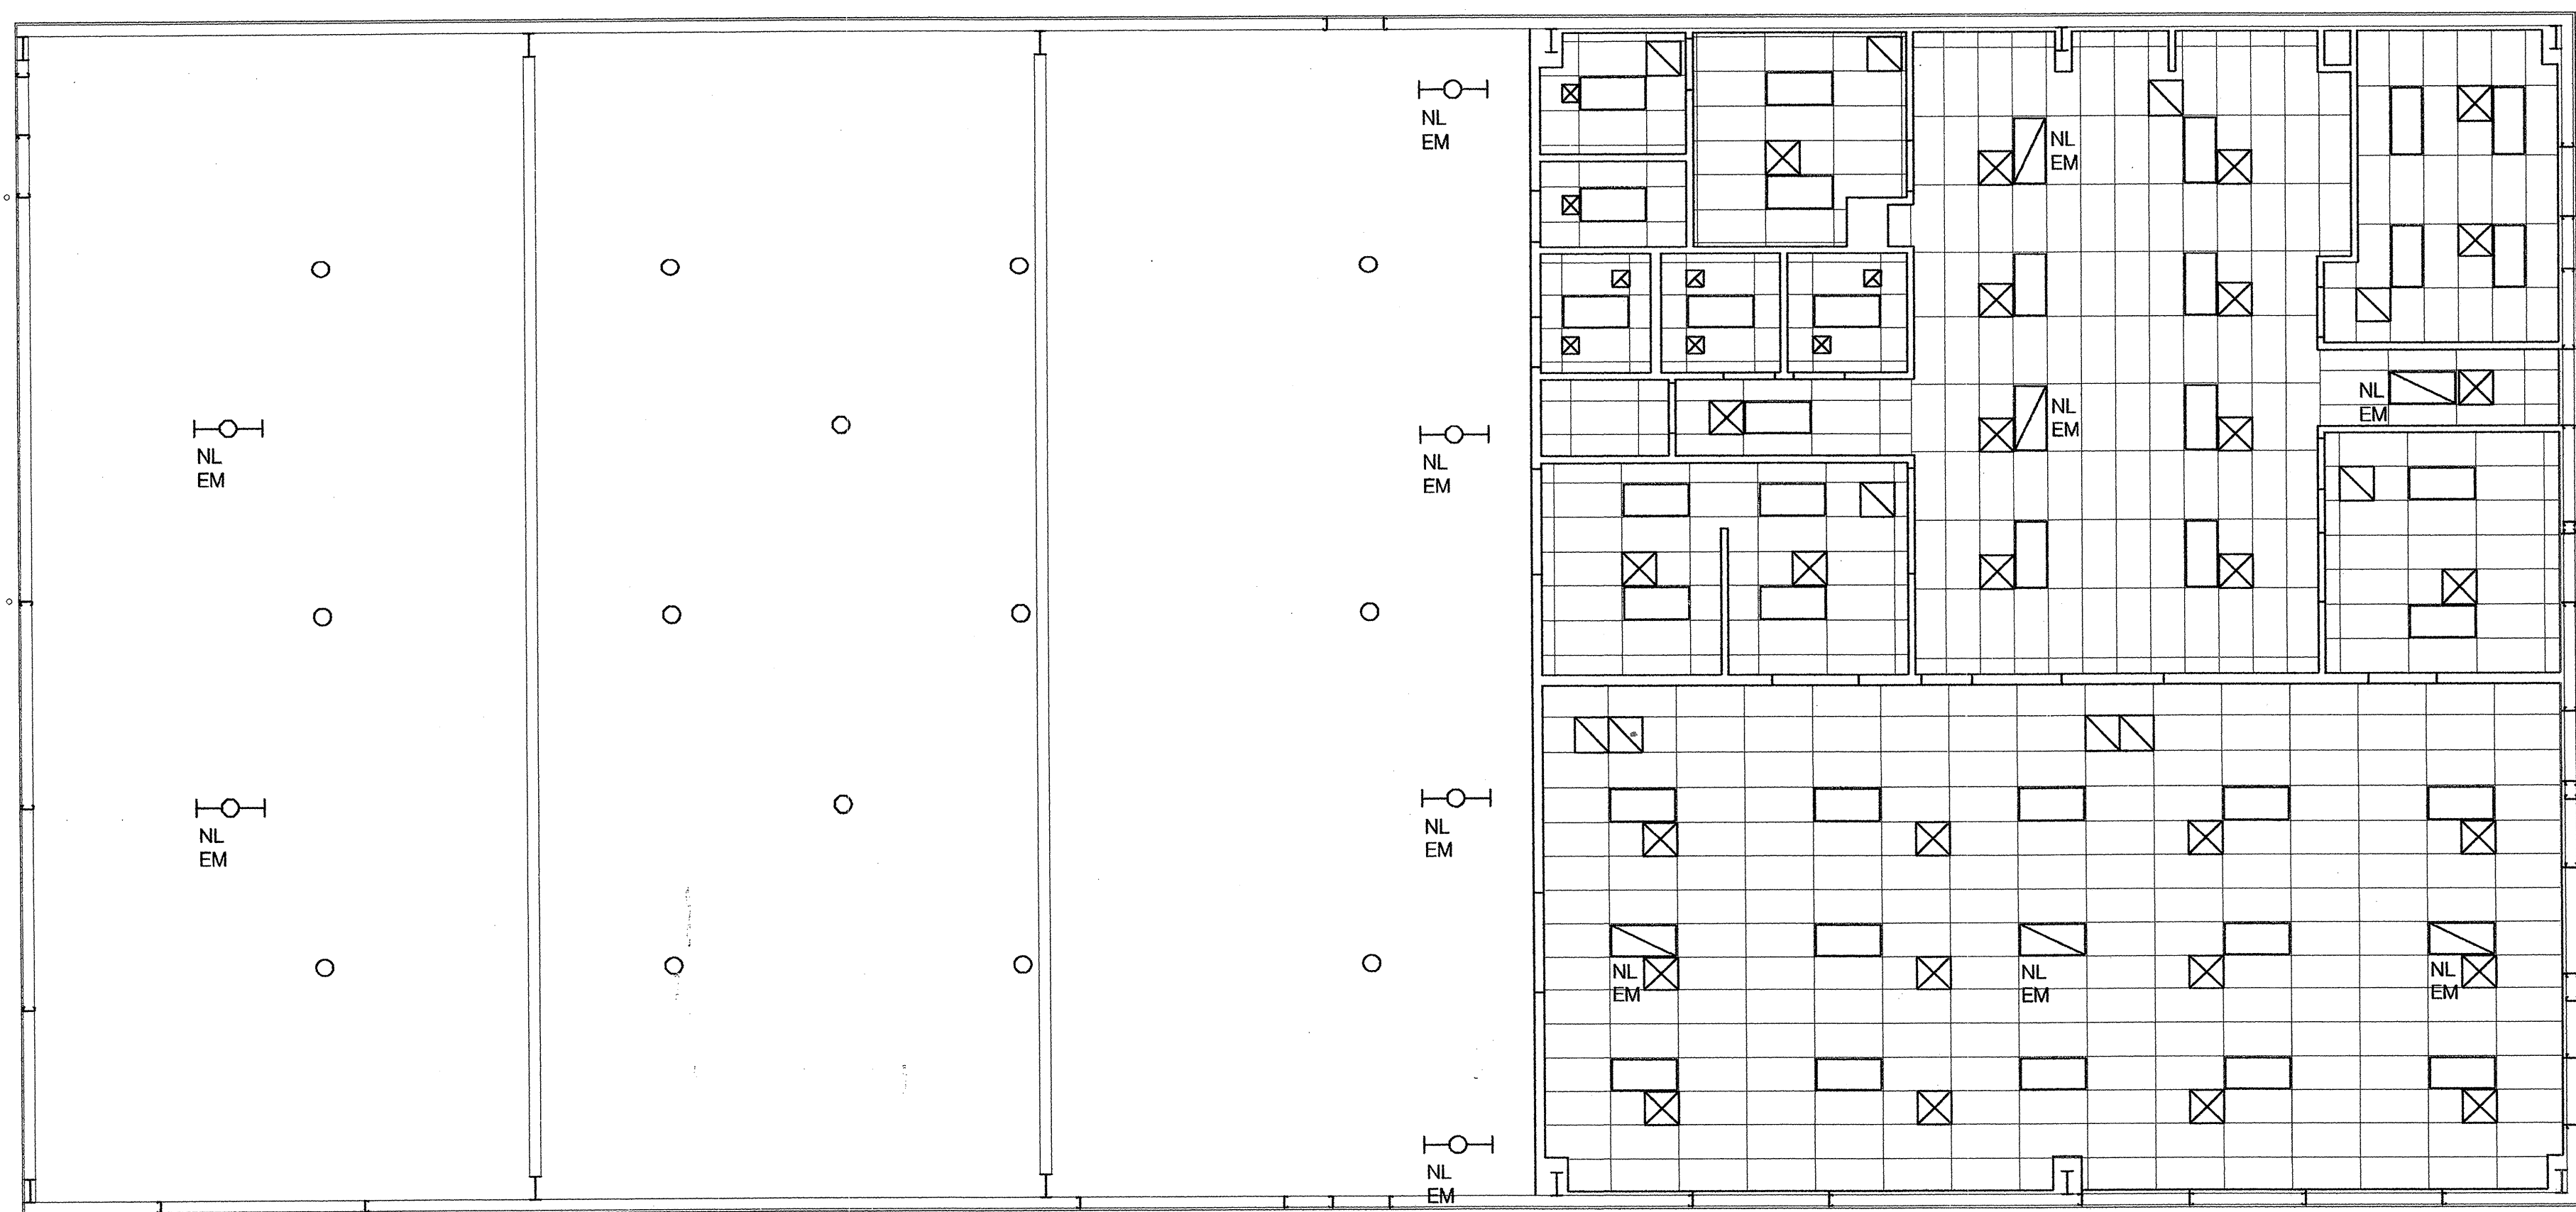

Reflected Ceiling Plan
North 1/8" = 1'-0"

Symbol	Description
	Lighting Fixture, see electrical drawings on page E4.1
	Lighting Fixture w/ Nightlight and/or Emergency, see electrical drawings on page E4.1
	Ceiling mounted lighting fixture, see electrical drawings on page E4.1
	Strip Lighting Fixture w/ Nightlight and/or Emergency, see electrical drawings on page E4.1
	Supply Air Grille, see mechanical drawings on page M1
	Return Air Grille, see mechanical drawings on page M1
	Exhaust Air Grille, see mechanical drawings on page M1

CITY OF PHOENIX
Department Services Department
BY:
STEVE BRAVARA
JUN 15 2007
This set of plans has been prepared for ARCHITECTURAL purposes only and shall not be construed as a contract. The City of Phoenix shall not be liable for any errors or omissions on the plans unless such errors or omissions are specifically noted to be in violation of any law or ordinance.

NATIONAL WATER WORKS
NORTH PHOENIX BRANCH
Parcel #209-03-104 A
2140 W Williams Drive
Phoenix, Arizona

job number
0658
title
Reflected Ceiling Plan
Legend

sheet number
A2.2